

INDEX OF SHEETS


SHEET	PLAN SHEET	TITLE
1		TITLE SHEET
2-10	CD-1 THRU CD-9	SURVEY AND CONTROL DIAGRAM
11-13	X-1 THRU X-3	TYPICAL SECTIONS
14-29	L-1 THRU L-16	LAYOUT
30-60	C-1 THRU C-31	CONSTRUCTION DETAILS
61-64	D-1 THRU D-4	DRAINAGE
65-70	SPD-1 THRU SPD-6	SIGNING AND PAVEMENT DELINEATION
71-73	E-1 THRU E-3	ELECTRICAL PLANS
74	CS-1	CONSTRUCTION AREA SIGNS
75-79	TR-1 THRU TR-5	TREE REMOVAL
80-83	EC-1 THRU EC-4	EROSION CONTROL
84-87	RW-1 THRU RW-4	RETAINING WALLS

COUNTY OF EL DORADO, CA
DEPARTMENT OF TRANSPORTATION


PROJECT PLANS FOR THE CONSTRUCTION OF
PONY EXPRESS TRAIL BICYCLE,
PEDESTRIAN AND ADA IMPROVEMENTS

IN THE COUNTY OF EL DORADO, DISTRICT V
IN THE TOWN OF POLLOCK PINES, ON PONY EXPRESS TRAIL, BETWEEN SANDERS DR AND SLY PARK RD


To be supplemented with Standard Plans and Specifications dated 2022, including the 2022 Revised
Standard Specifications, of the California Department of Transportation, unless otherwise noted.

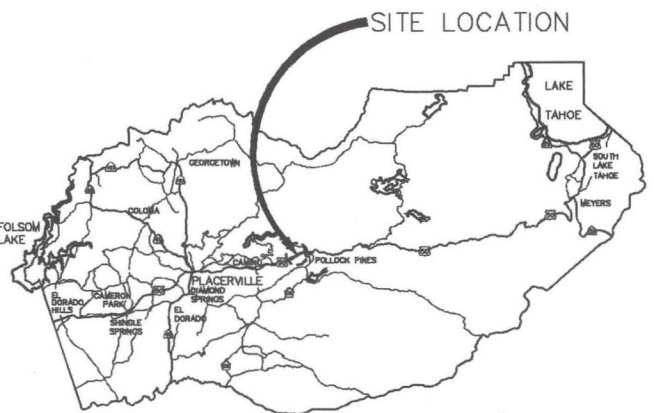

VICINITY MAP
COUNTY OF EL DORADO

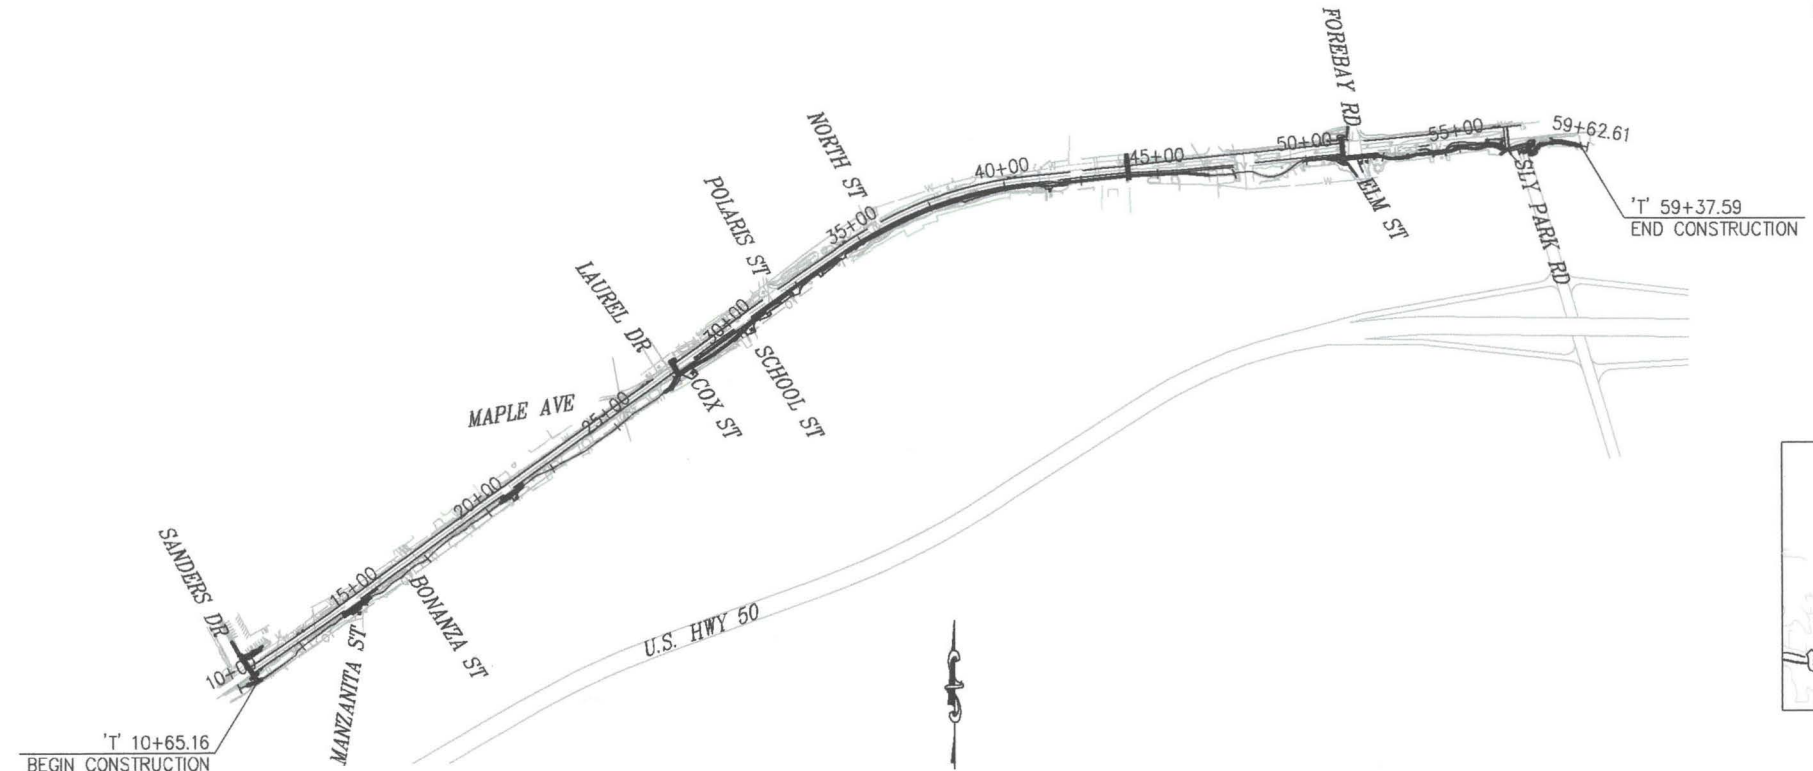

SITE PLAN
SCALE: 1"=300'

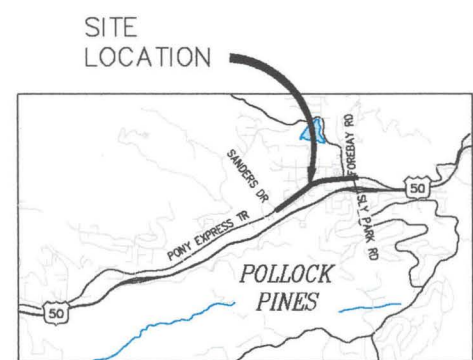

LOCATION MAP
NOT TO SCALE

FEDERAL AID PROJECT
CML 5925 (176)

CONTRACTOR'S LICENSE CLASSIFICATION: Bidders shall be properly licensed to perform the Work pursuant to the State Contractor's License Act (Business and Professions Code section 7000 et seq.) and shall possess a CLASS A LICENSE or equivalent combination of Classes required by the categories and type of Work included in the Contract Documents and Plans. Failure of the successful Bidder to obtain proper and adequate licensing at the time bids are submitted shall constitute a failure to execute the Contract, and forfeiture as provided under that section.

REVISIONS		
MARK	DATE	BY



SUBMITTED BY: DATE: 06/29/23
CIVIL ENGINEER
STATE OF CALIFORNIA NO. C72291

BOARD OF SUPERVISORS
I JOHN HIDAHL
II GEORGE TURNBOO
III WENDY THOMAS
IV LORI PARLIN
V BROOKE LAINE


COUNTY OF EL DORADO
DEPARTMENT OF TRANSPORTATION
(530) 621-5900
2850 FAIRLANE CT
PLACERVILLE, CA 95667

ADOPTED AND APPROVED BY:
WENDY THOMAS, CHAIR, EL DORADO COUNTY BOARD OF SUPERVISORS
DATE: 7/10/23
APPROVED BY:
RAFAEL MARTINEZ, DIRECTOR, DEPARTMENT OF TRANSPORTATION
DATE: 7/10/23
APPROVED BY:
MATTHEW D. SMETZER, P.E., NO. C38832, DEPUTY DIRECTOR, ENGINEERING

PW NO. CIP NO. 36109010
PONY EXPRESS TRAIL BICYCLE,
PEDESTRIAN AND ADA
IMPROVEMENTS
TITLE SHEET
SHEET 1 OF 87


ORIGINAL SCALE IS IN INCHES
Drawing name: Z:\Civil 3D Projects\97019 Pony Express Class 2 BP\CADD Files\Sheets\L-Sheets.dwg Layout Tab: L-8 Jul 21, 2023 -- 10:47am dmankowski

FOR REDUCED PLANS
2
1
0

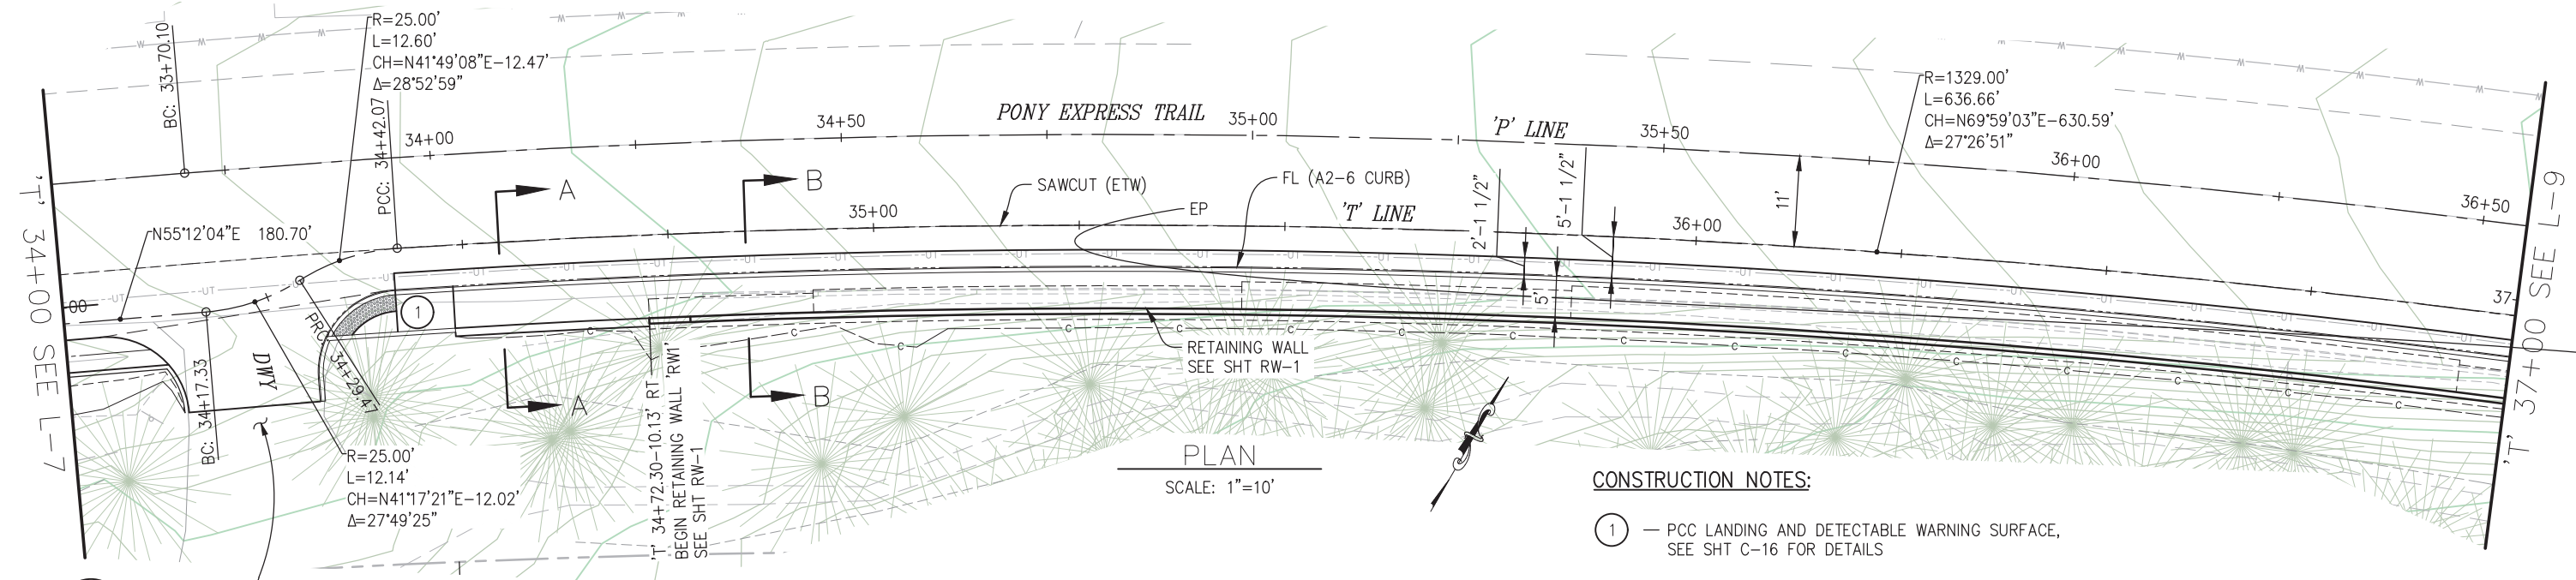


PLAN
SCALE: 1"=10'


CONSTRUCTION NOTES:
① — PCC LANDING AND DETECTABLE WARNING SURFACE, SEE SHT C-16 FOR DETAILS

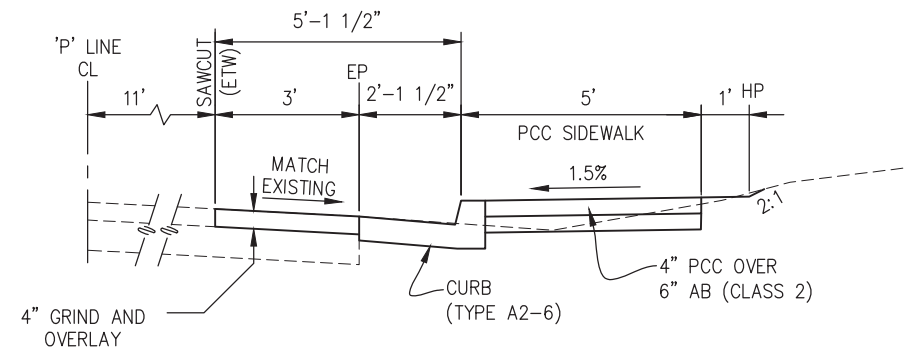

SECTION A-A
NTS

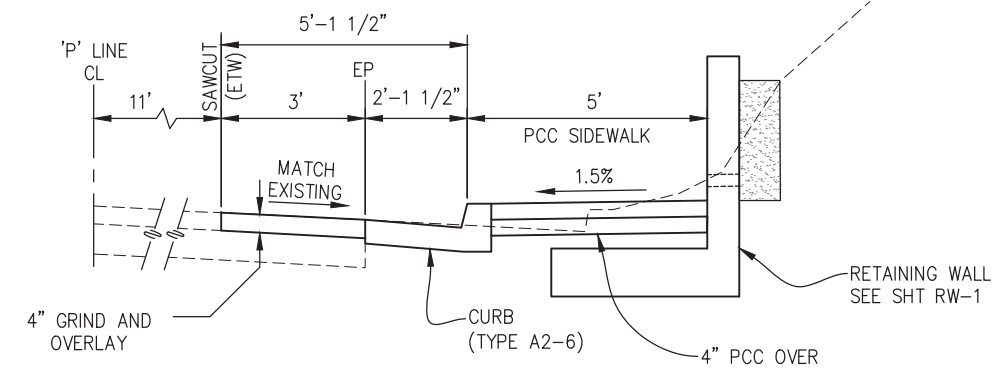

SECTION B-B
NTS

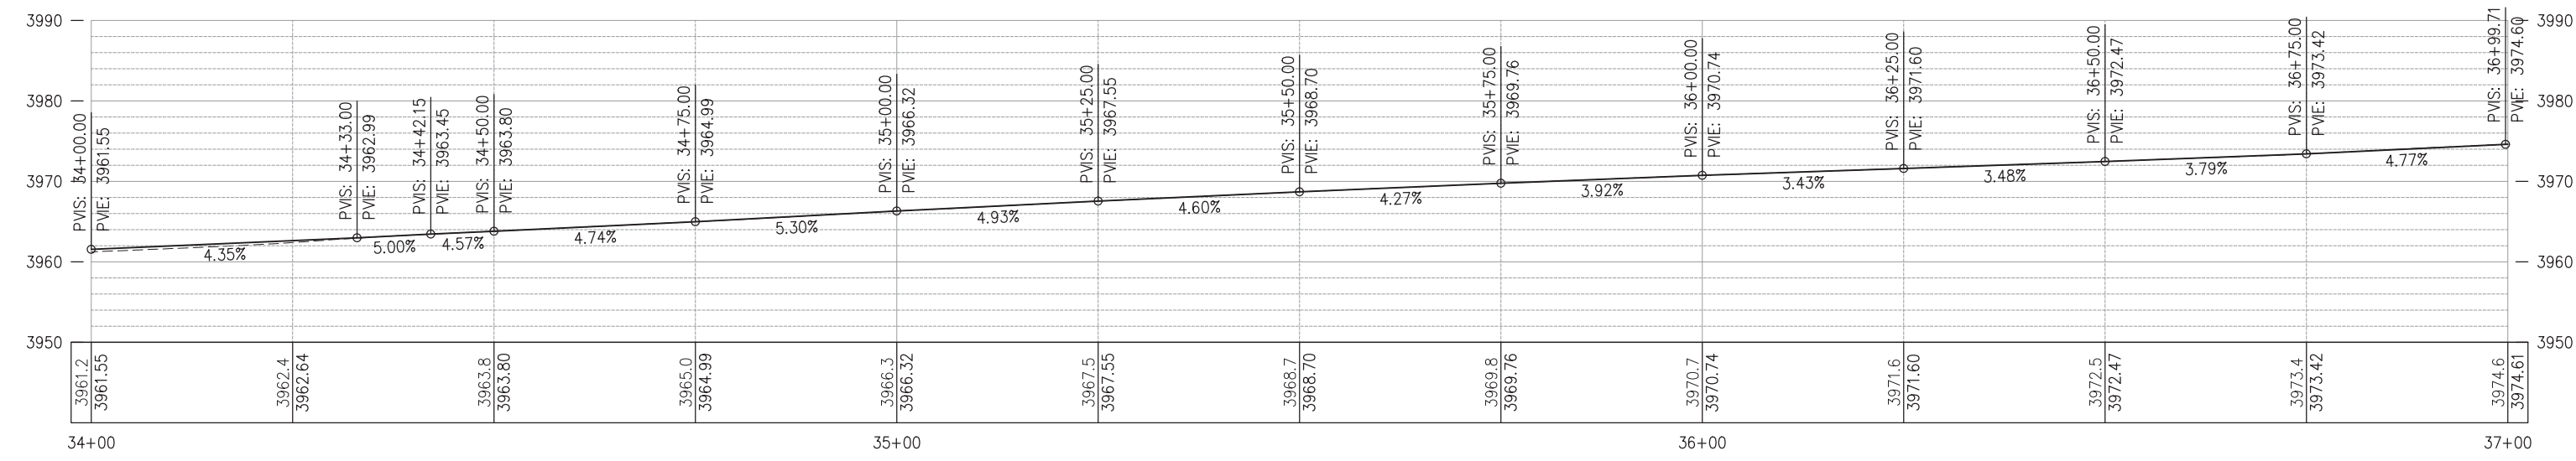

PROFILE
SCALE: 1"=10' H,V

REVISION	NUMBER	DATE	DESCRIPTION	BY



PREPARED UNDER THE SUPERVISION OF :

REGISTERED CIVIL ENGINEER
6/29/23
DATE:

DESIGNED: BF
CHECKED: BF
ROAD NUMBER: 025
DRAWN: SGM
DATE: 04/10/23




COUNTY OF EL DORADO
DEPARTMENT OF TRANSPORTATION


PONY EXPRESS TRAIL BICYCLE,
PEDESTRIAN AND ADA IMPROVEMENTS

LAYOUT
AS SHOWN
SHEET
L-8
21 OF 87
W.O. No. 97019

ORIGINAL SCALE: 1"=10' H, V
Drawing name: Z:\Civil 3D Projects\97019 Pony Express Trail\97019 Pony Express Class 2 BP\CADD Files\Sheets\L-Sheets.dwg Layout Tab: L-9 Jul 21, 2023 10:47am dmankowski

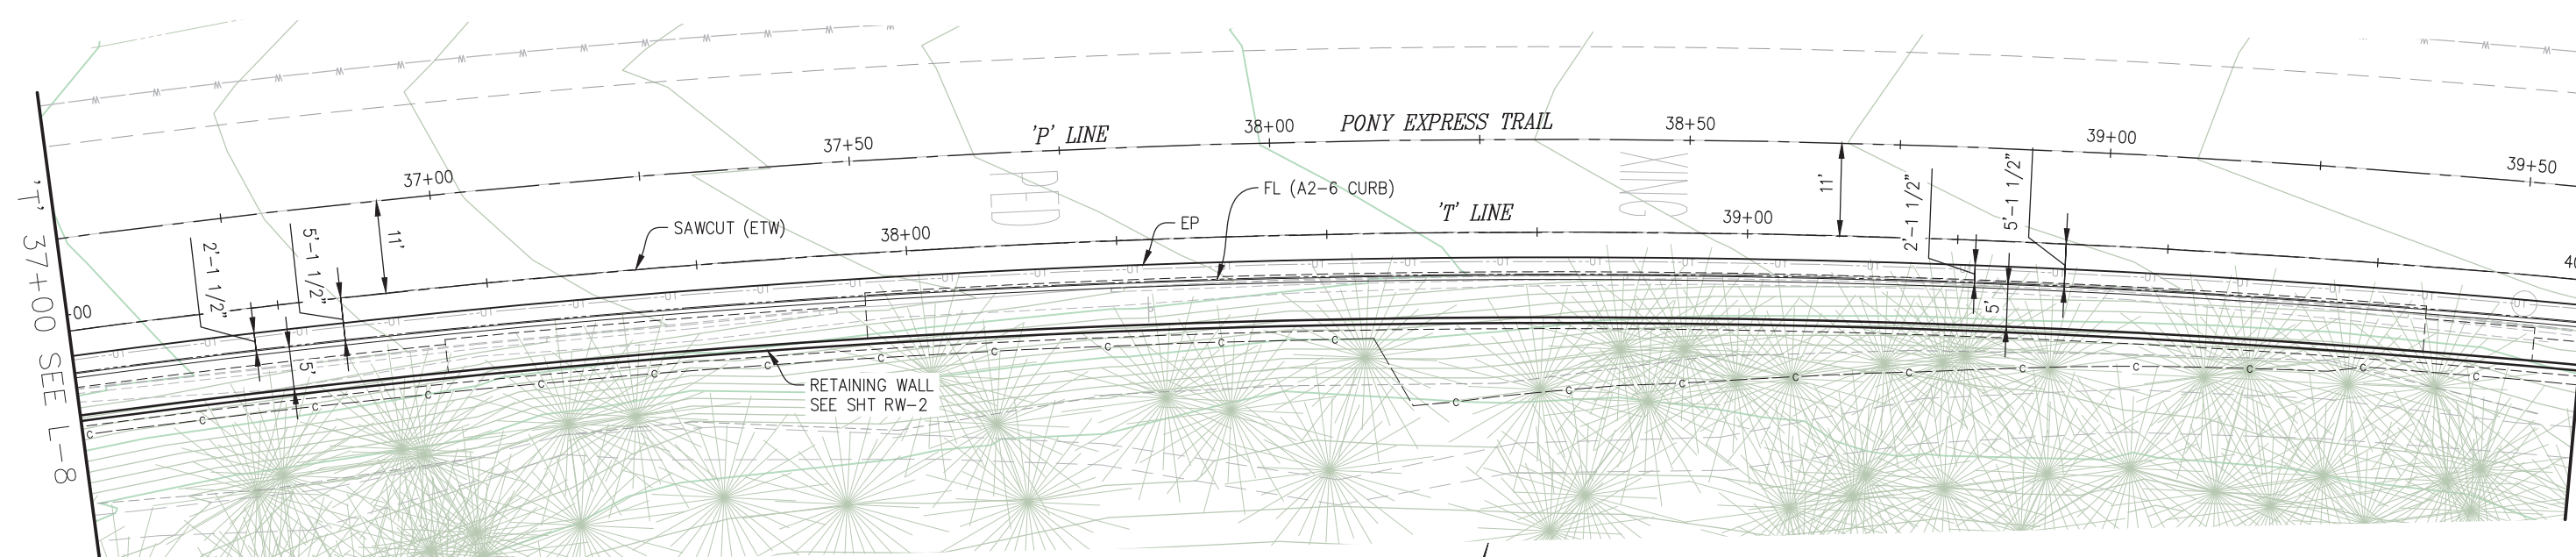

PLAN
SCALE: 1"=10'

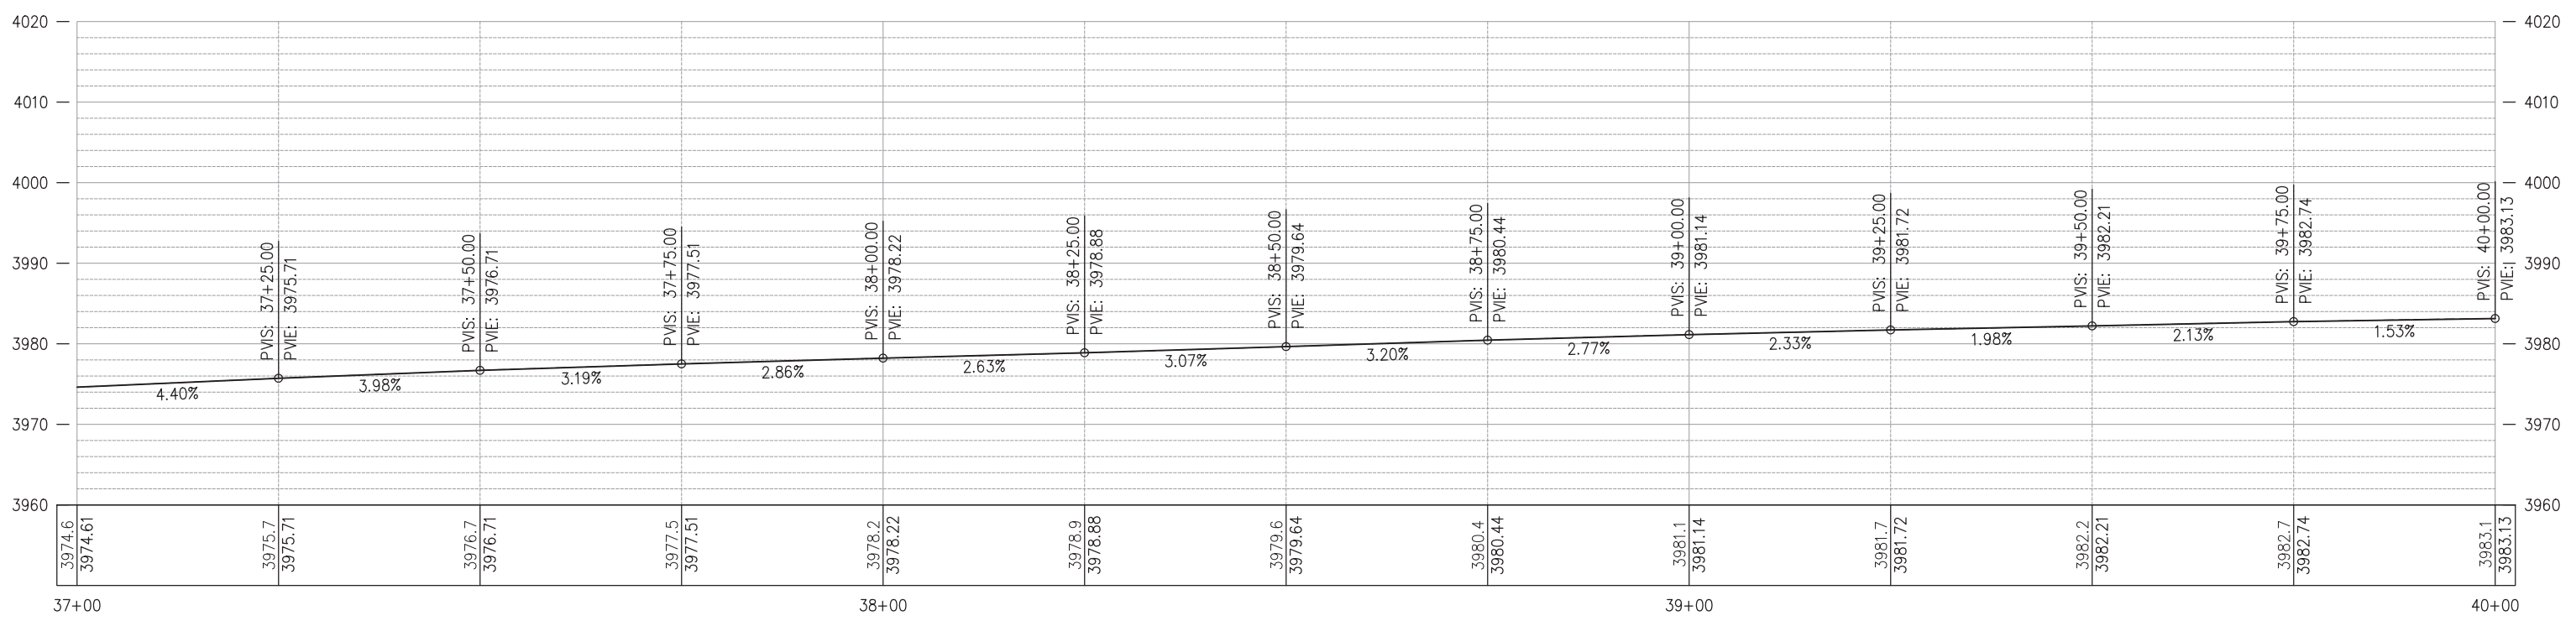

PROFILE
SCALE: 1"=10' H, V

FOR REDUCED PLANS
0 1 2

REVISION	NUMBER	DATE	DESCRIPTION	BY



PREPARED UNDER THE SUPERVISION OF :

REGISTERED CIVIL ENGINEER
DATE: 6/29/23

DESIGNED: BF
CHECKED: BF
ROAD NUMBER: 025
DRAWN: SGM
DATE: 04/10/23





COUNTY OF EL DORADO
DEPARTMENT OF TRANSPORTATION

PONY EXPRESS TRAIL BICYCLE,
PEDESTRIAN AND ADA IMPROVEMENTS

LAYOUT
AS SHOWN
SHEET
L-9
22 OF 87
W.O. No. 97019

FOR REDUCED PLANS
ORIGINAL SCALE: 1"=10'
Drawing name: Z:\Civil 3D Projects\97019 Pony Express Class 2 BP\CADD Files\Sheets\L-Sheets.dwg
Layout Tab: L-10 Jul 21, 2023 10:47am dmarkowski

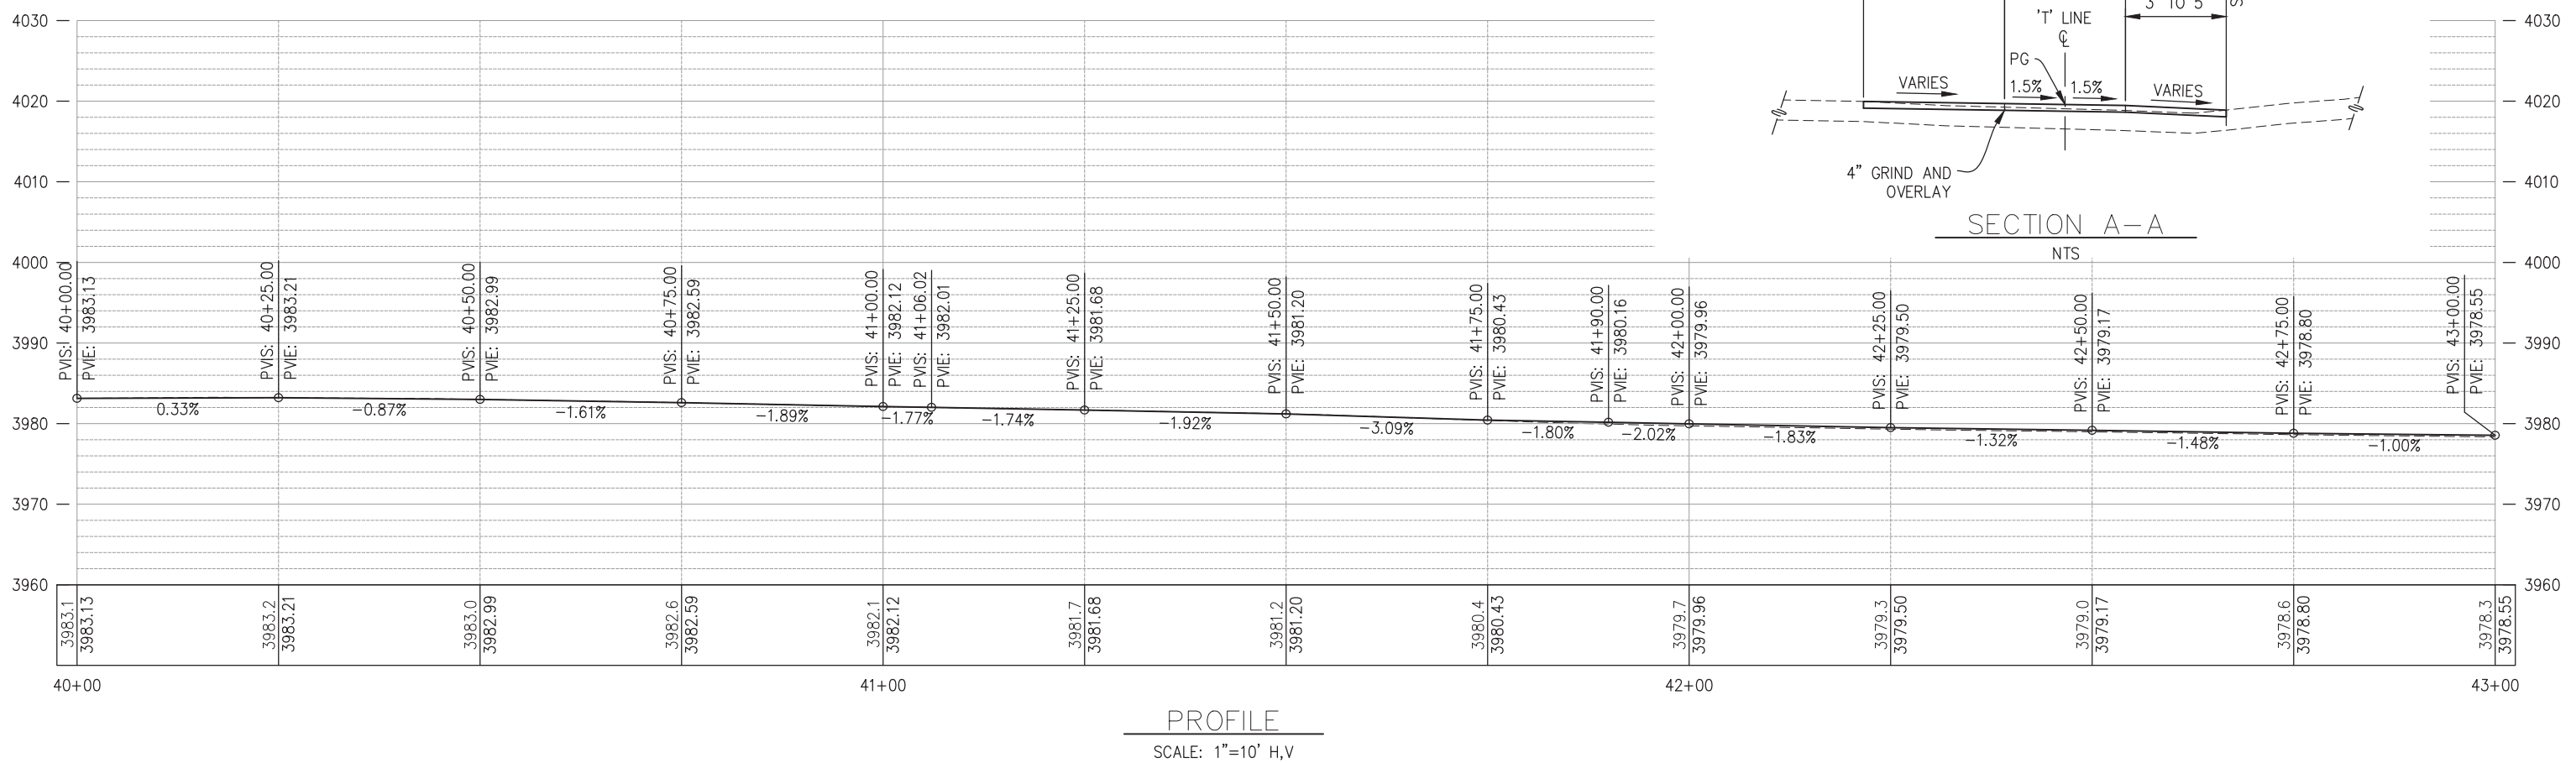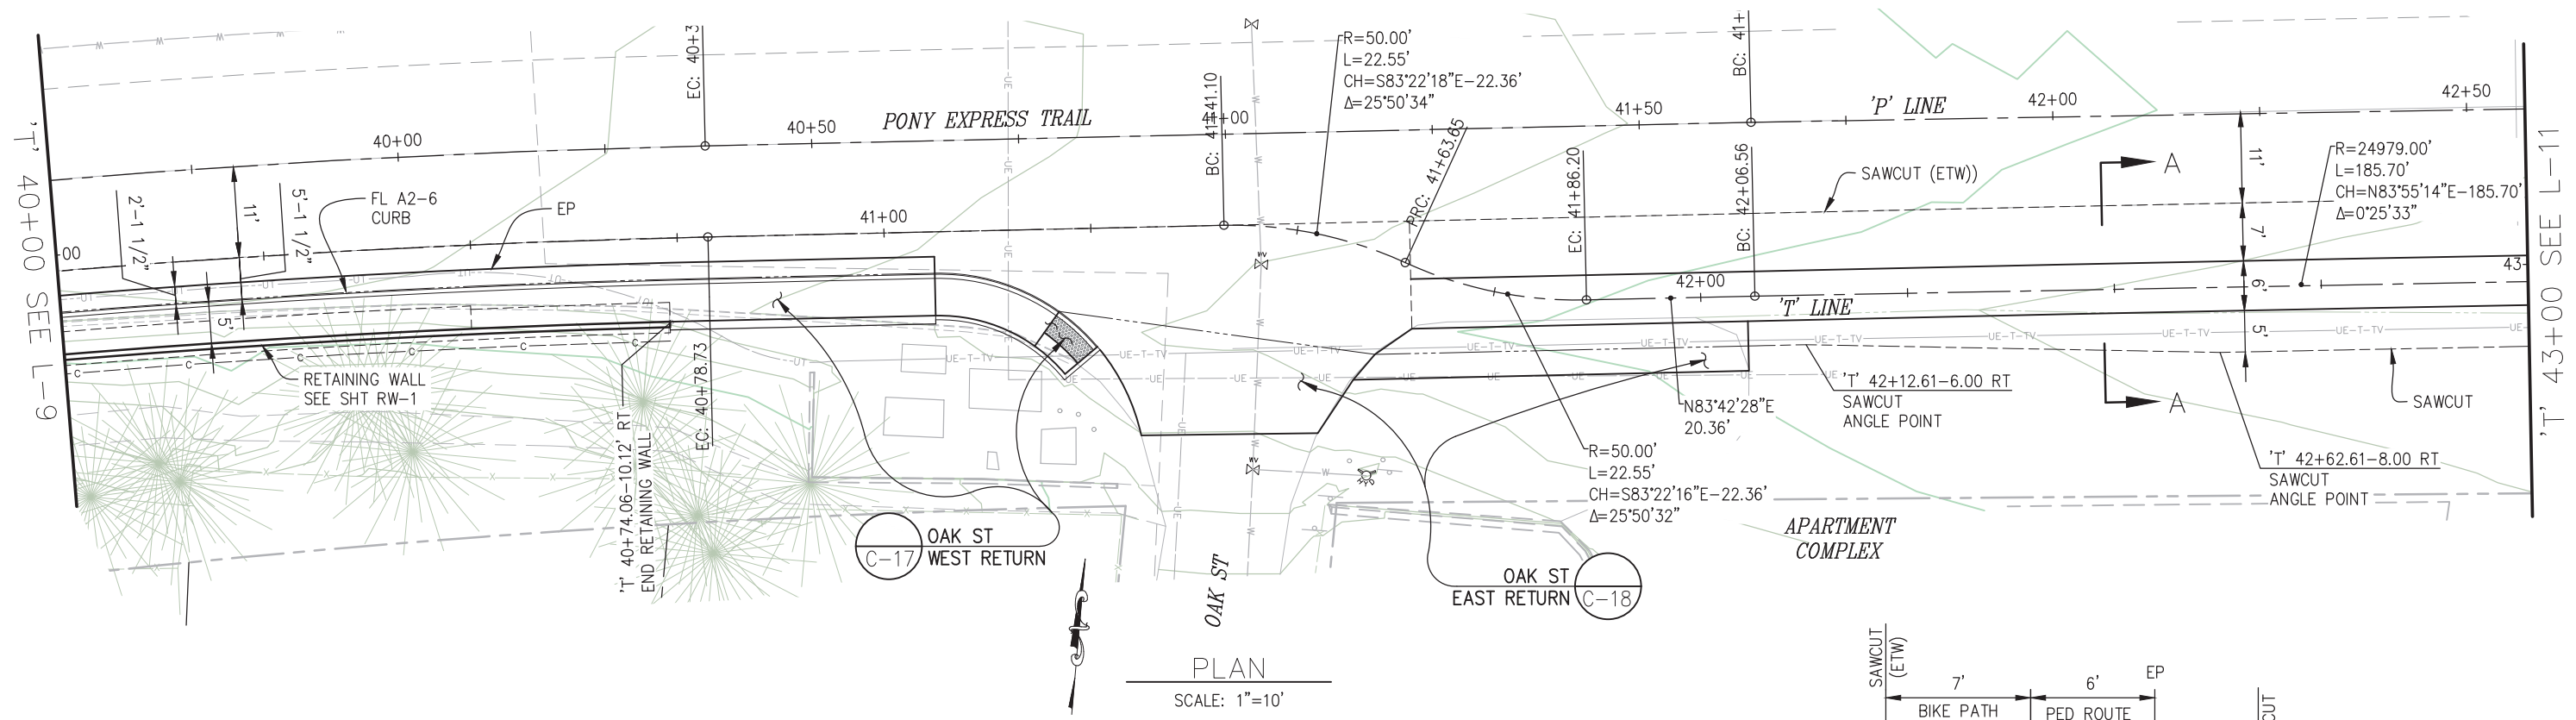

REVISION	NUMBER	DATE	DESCRIPTION	BY



PREPARED UNDER THE SUPERVISION OF :
[Signature]
REGISTERED CIVIL ENGINEER
DATE: 6/29/23

DESIGNED: BF
CHECKED: BF
ROAD NUMBER: 025
DRAWN: SGM
DATE: 04/10/23



COUNTY OF EL DORADO
DEPARTMENT OF TRANSPORTATION


PONY EXPRESS TRAIL BICYCLE,
PEDESTRIAN AND ADA IMPROVEMENTS

LAYOUT AS SHOWN
SHEET L-10
23 OF 87
W.O. No. 97019

Example of an improved crosswalk with rapid flashing beacons



Pony Express Trail @ Forebay Rd

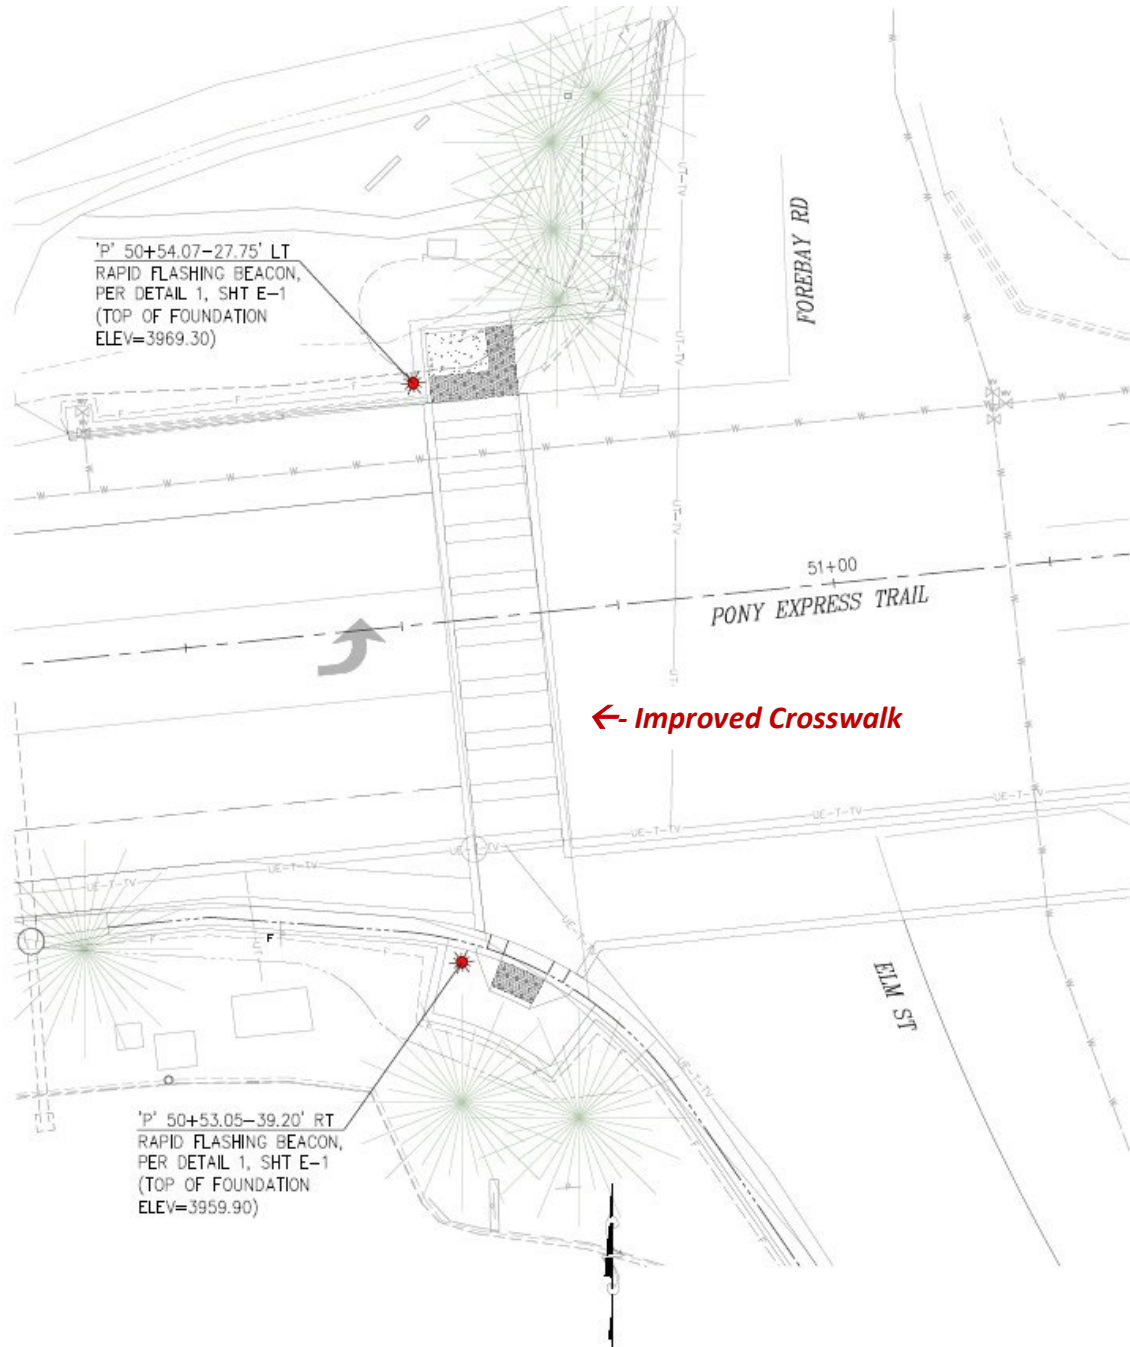


PRELIMINARY



= Rapid Flashing Beacon

Pony Express Trail near 50 Grand/ Burger Barn

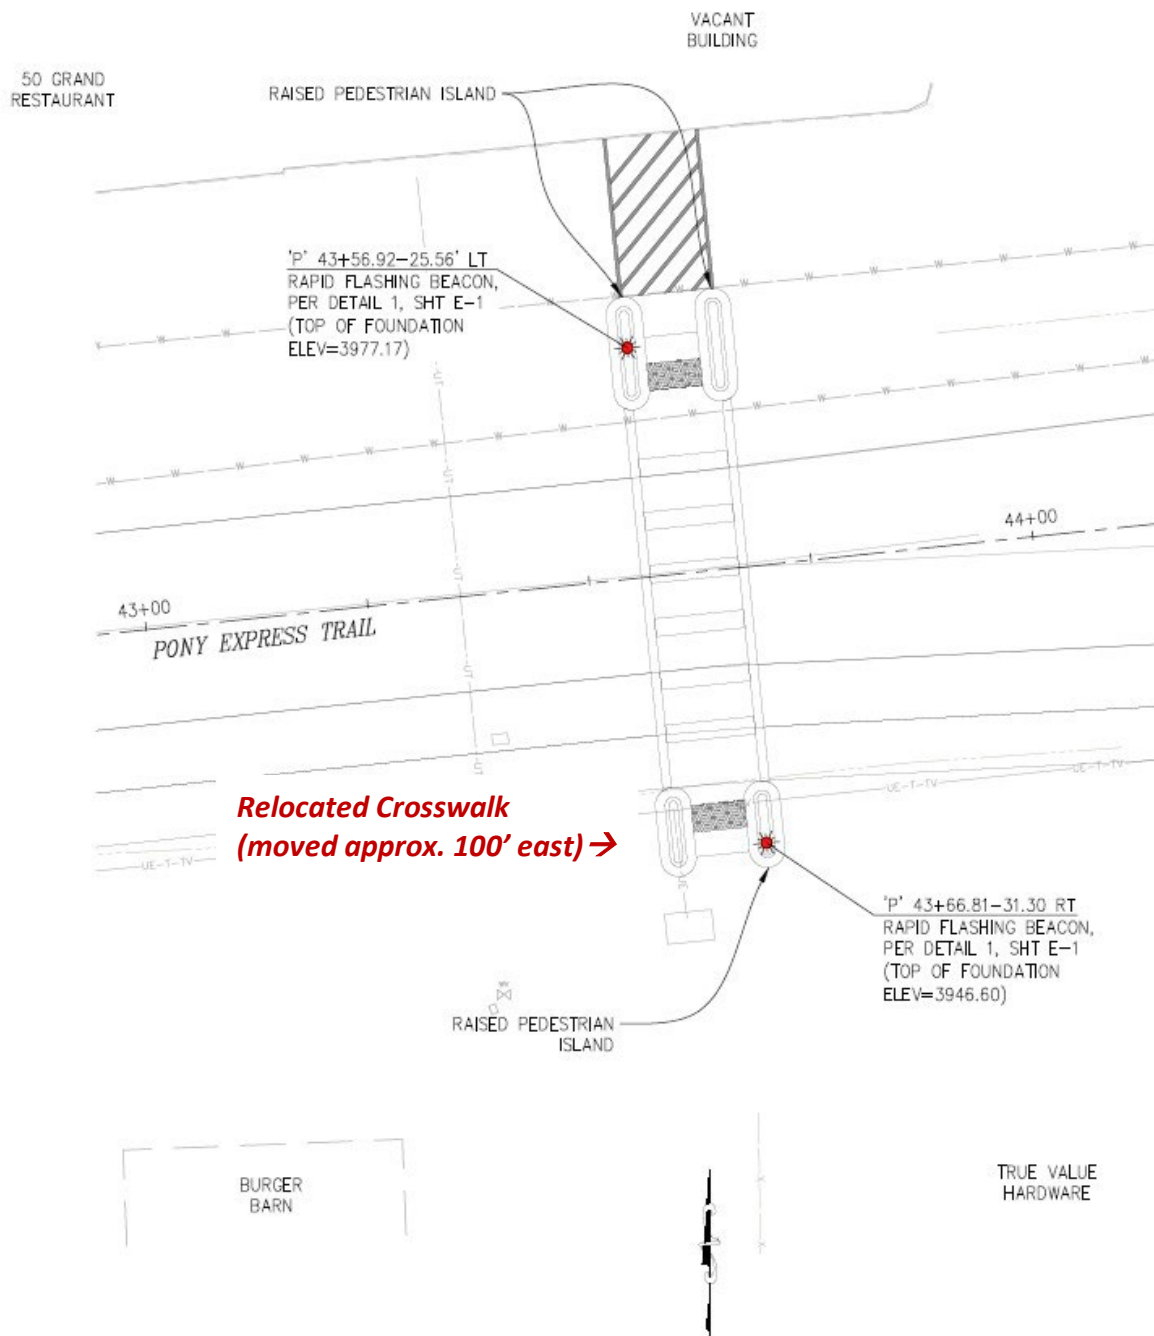


PRELIMINARY



= Rapid Flashing Beacon

Pony Express Trail @ Cox St

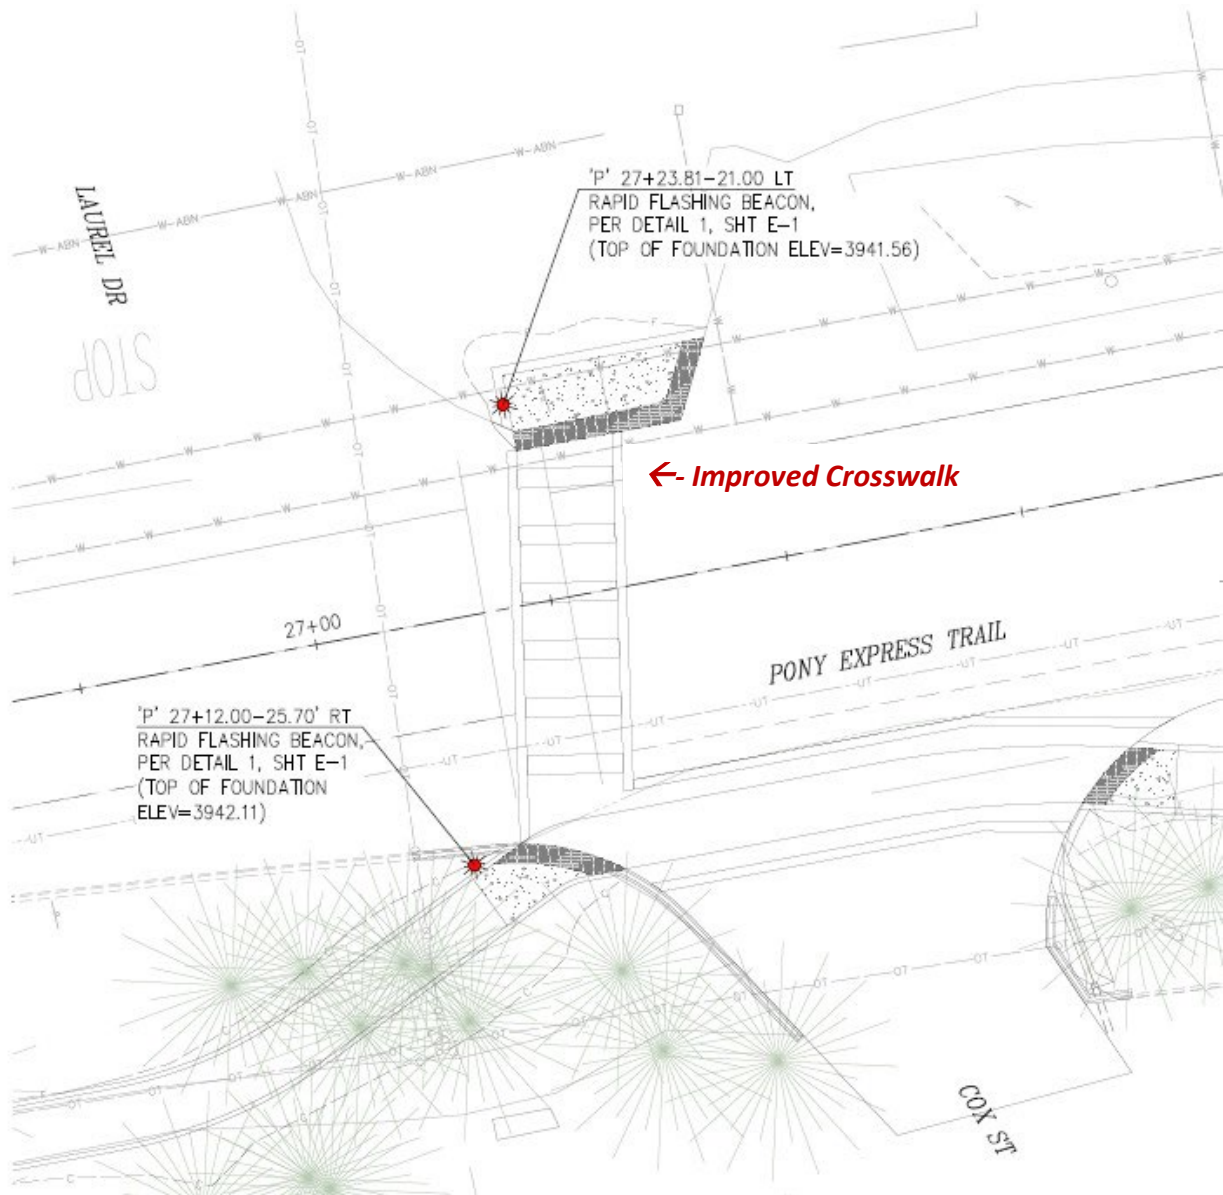


PRELIMINARY



= Rapid Flashing Beacon

Pony Express Trail @ Sanders Dr

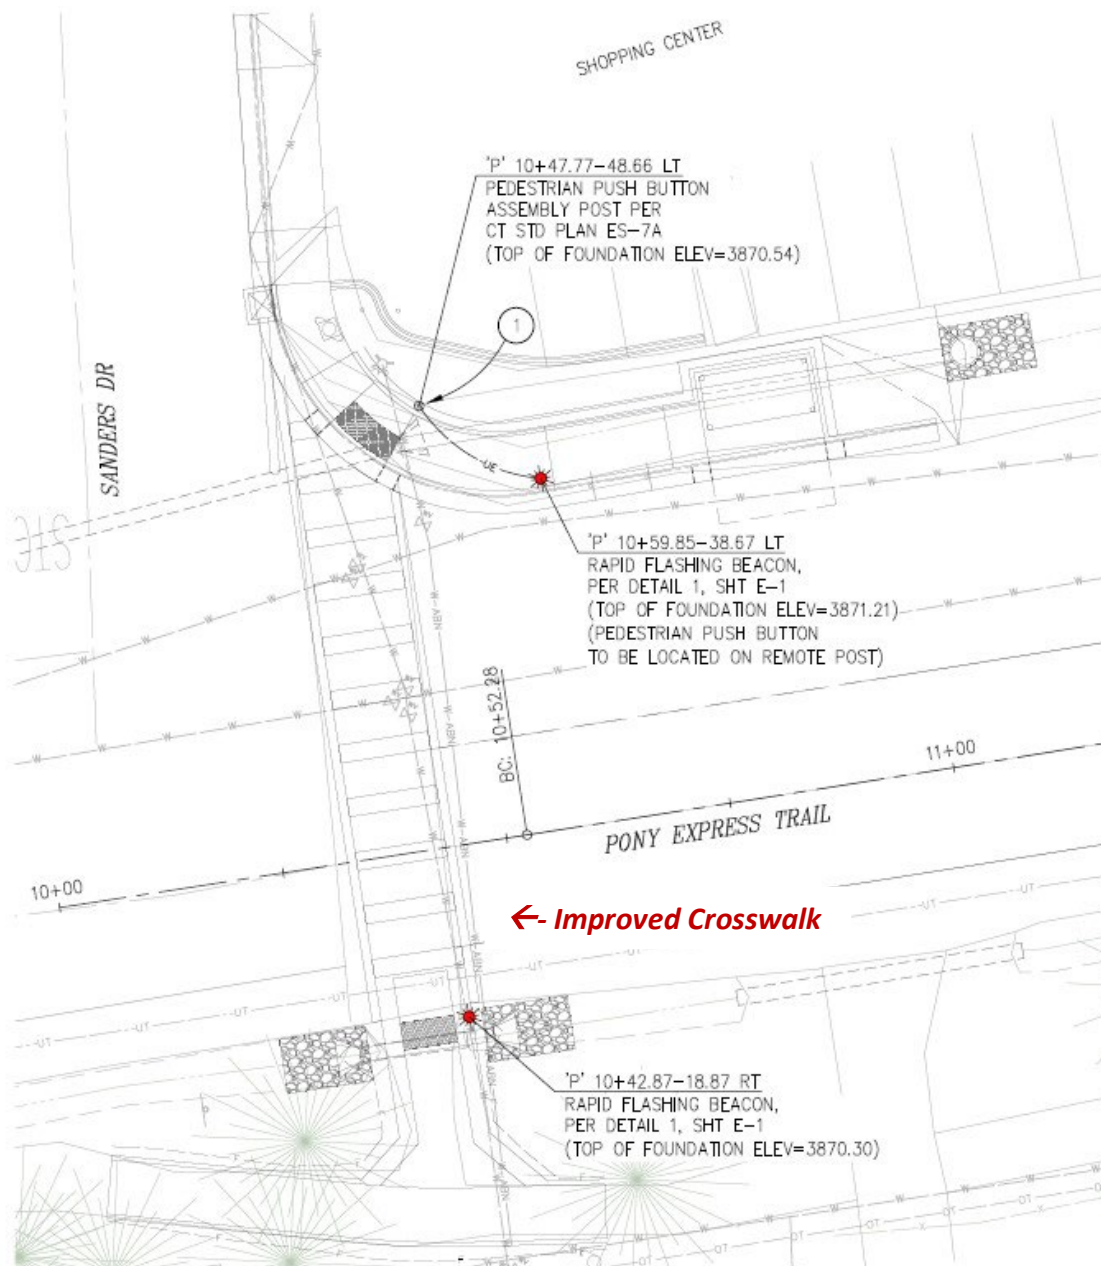

PRELIMINARY



= Rapid Flashing Beacon